



REVISIONS:	BY:

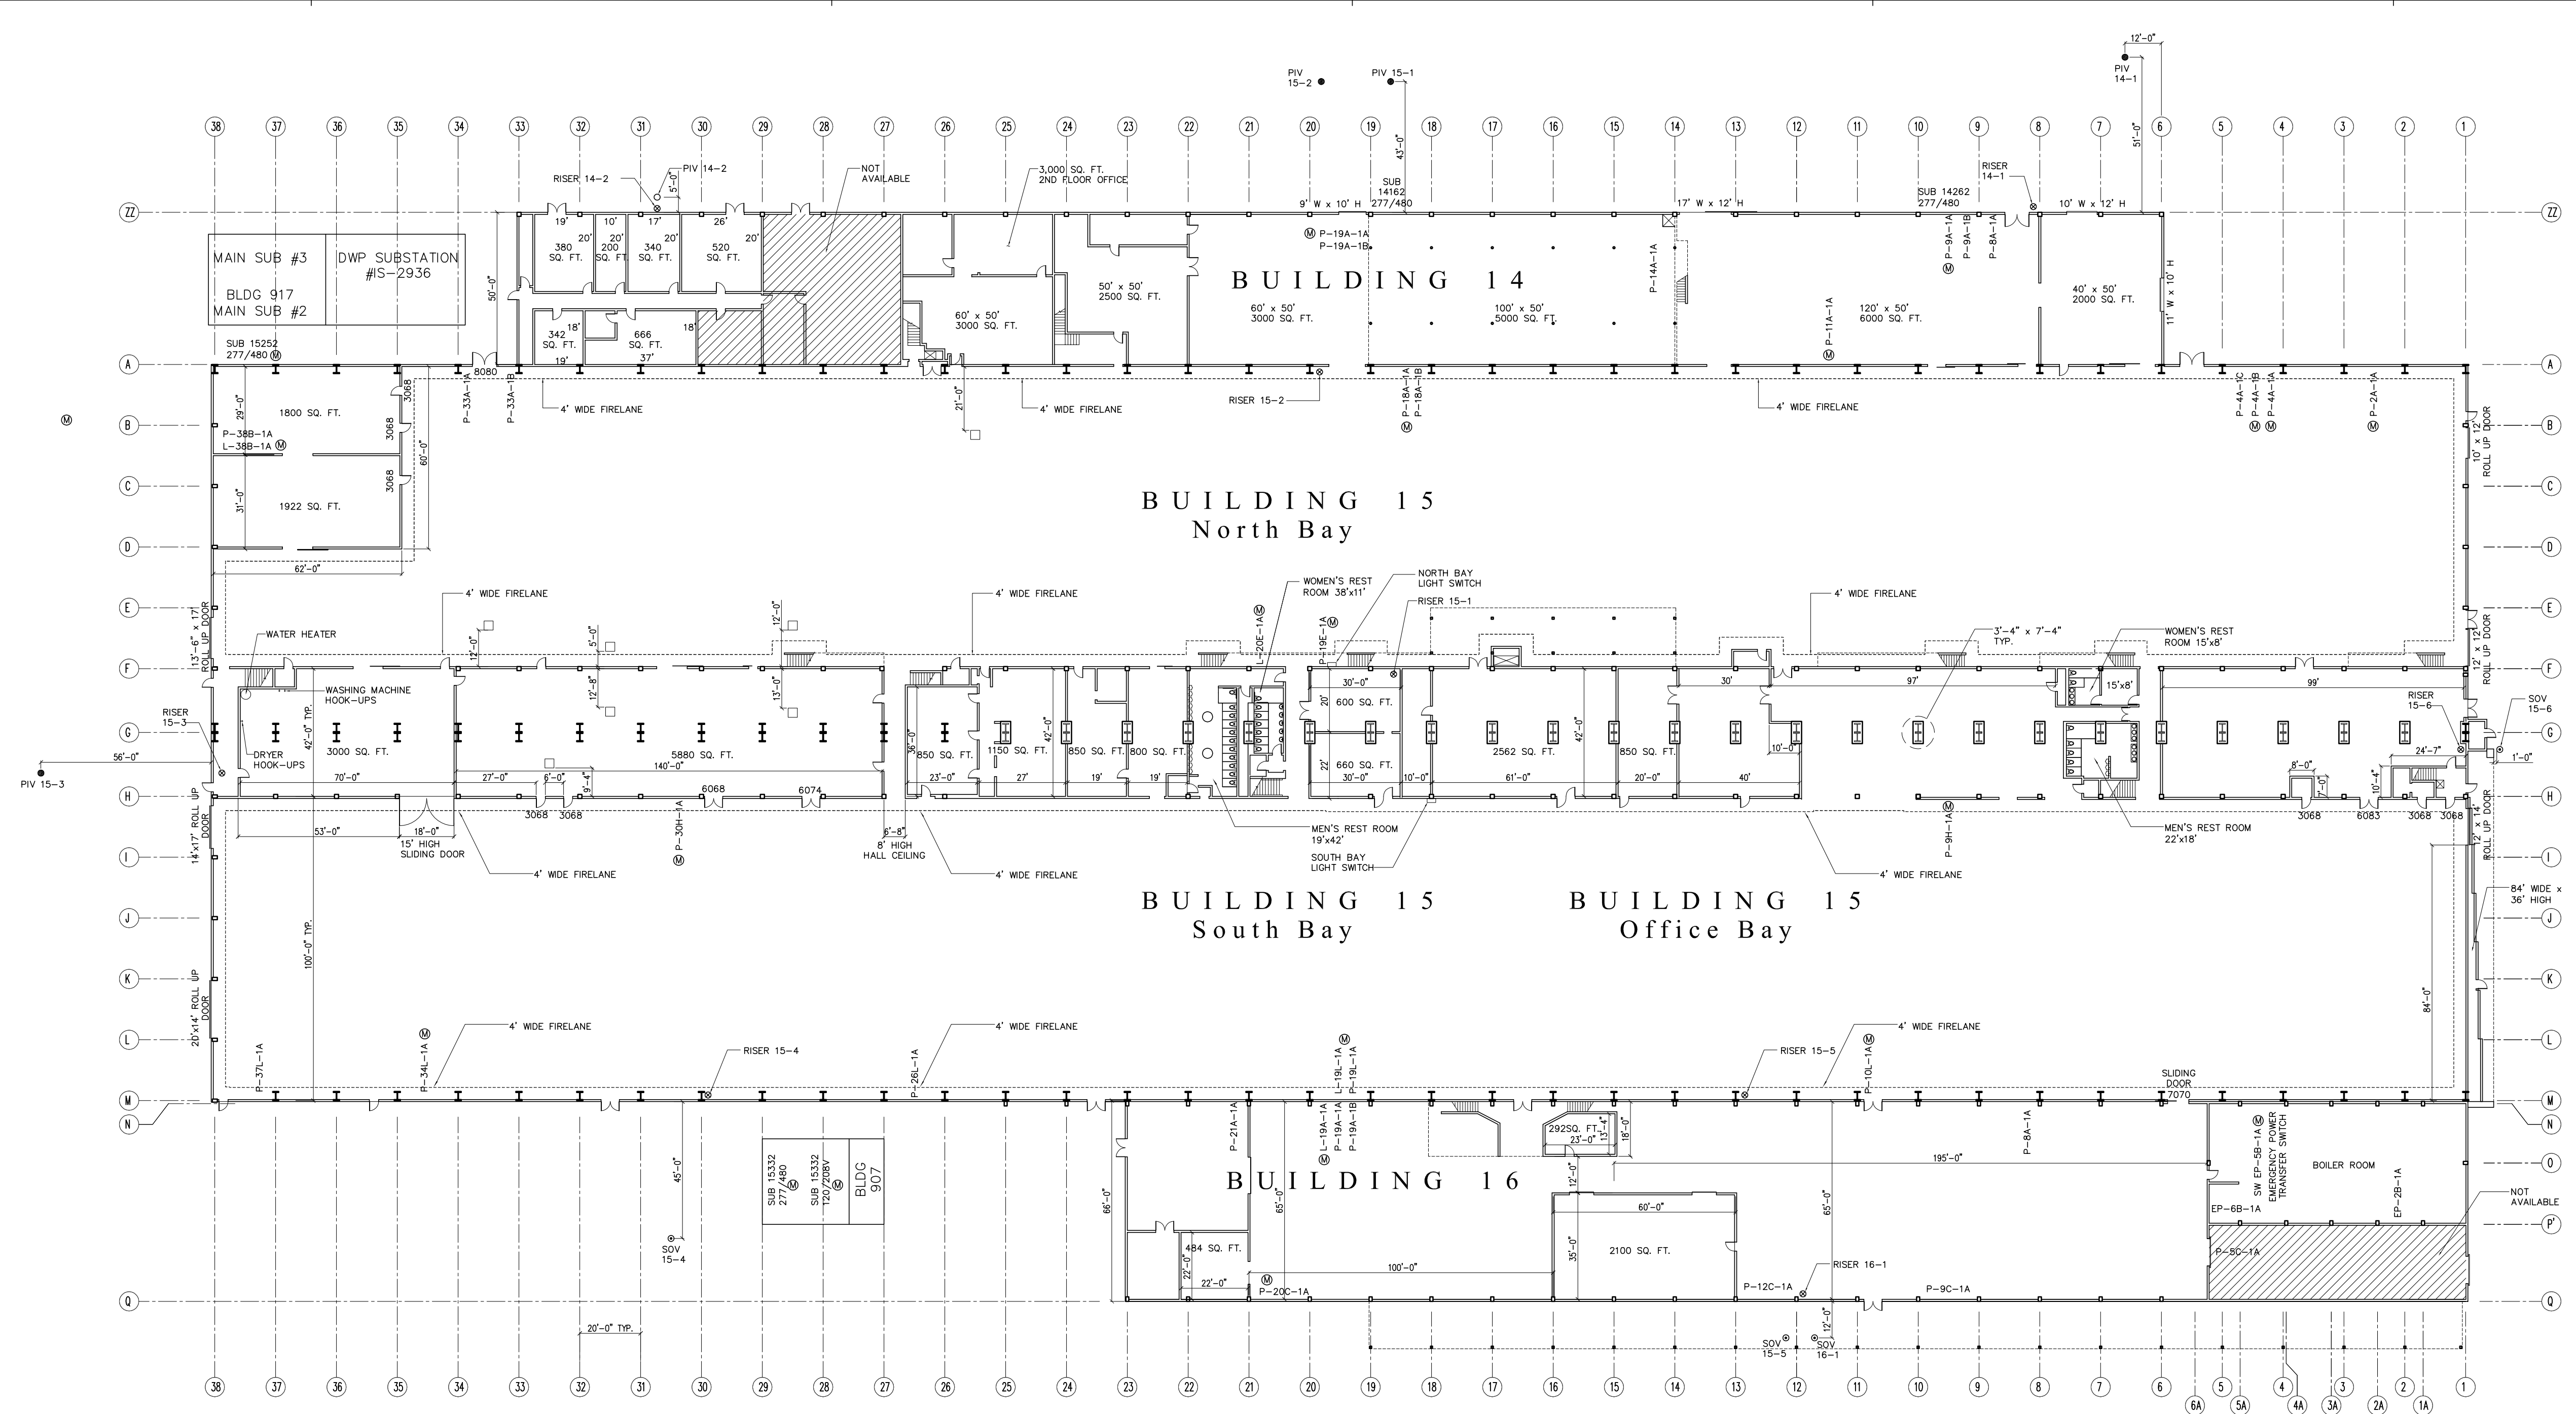

LEGEND:
 ⊕ METER
 SW SWITCH
 T TRANSFORMER

LEGEND:
 ⊕ FIRE SPRINKLER RISER
 ⊕ PDST INDICATOR VALVE (PIV)
 ⊕ SHUT-OFF VALVE (SOV)
 (SUB SURFACE)

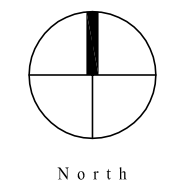

Buildings 14, 15 and 16 Existing Ground Floor Plan

STAGES AT PLAYA VISTA
 5600 Campus Center Drive
 Playa Vista, California 90094
 Tel: (310) 827-4800



DRAWN:
CHECKED:
DATE: JAN. 2005
SCALE: 1/32"=1'-0"
JOB NO:
SHEET NUMBER:

A1